


NOTE	
Contractors to take final dimensions on site	
LEGEND	
NEW WORKS	
FLUSH PLASTER SKINHEAD 200mm deep	
WALL LIGHT	
DOWN LIGHT	
CEILING LIGHT	
600 x 600 FLOOR TILE	
GRANITE FLOOR TILE	

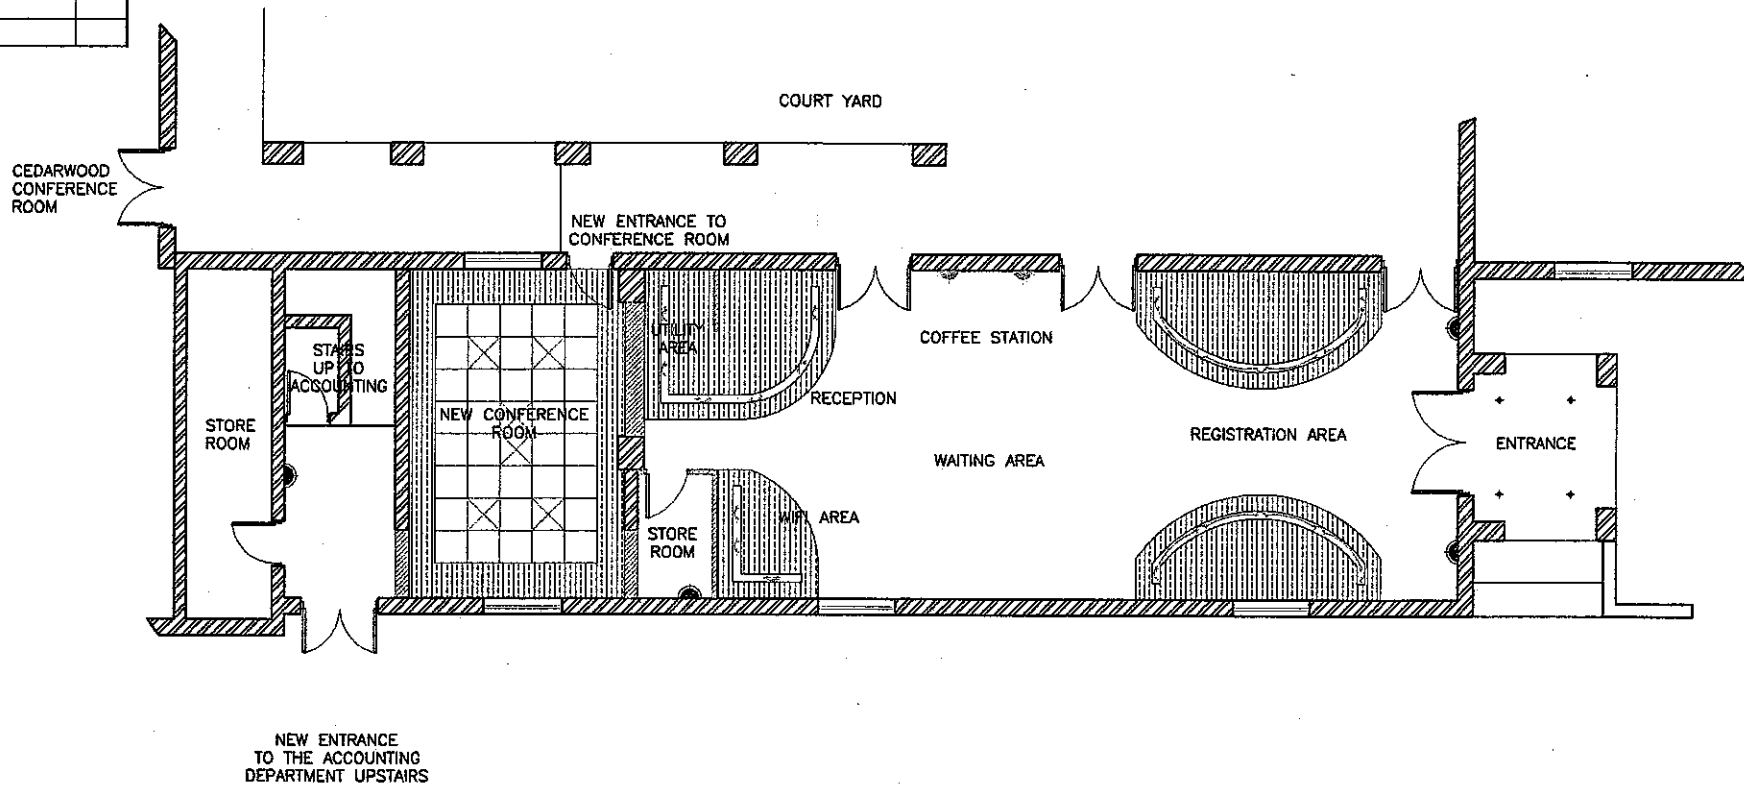

delineo projects
 interior design and project management
 tel: (011) 883-3218 fax: (011) 883-3209
 e-mail: design@dpd.co.za
 90 11th St. Parkmore 2196 PO Box 55522 Northlands 2116

CLIENT :

BIRCHWOOD
 HOTEL & CONFERENCE CENTRE

DRAWING TITLE: Ceiling & Lighting Layout

DWG No: BIRCHWOOD.AtriumCentre.00.dwg

DWG DATE:	SCALE:	DRAWN BY:	REV No:	REV DATE:
11/11/2008	1:100	M.HOBSON	00	12/11/2008